

ALL DIMENSIONS ARE IN METER

NO.	REVISION	DATE	APP.

CONTRACTOR

 شركة أبحاث وتصميم

CONSULTANT

 شركة أبحاث وتصميم

CLIENT :
 MINISTRY OF HIGHER EDUCATION & SCIENTIFIC RESEARCH

PROJECT NO :

PROJECT TITLE :
 MINISTRY OF HIGHER EDUCATION CONFERENCE HALL

DRAWING NO :

SCALE :

DRAWING TITLE :
GROUND FLOOR PLAN

DRAWN BY :


CHECKED BY :

APPROVED BY :

FILE NAME :

DATE :
 MAR / 2014

SHEET NO :

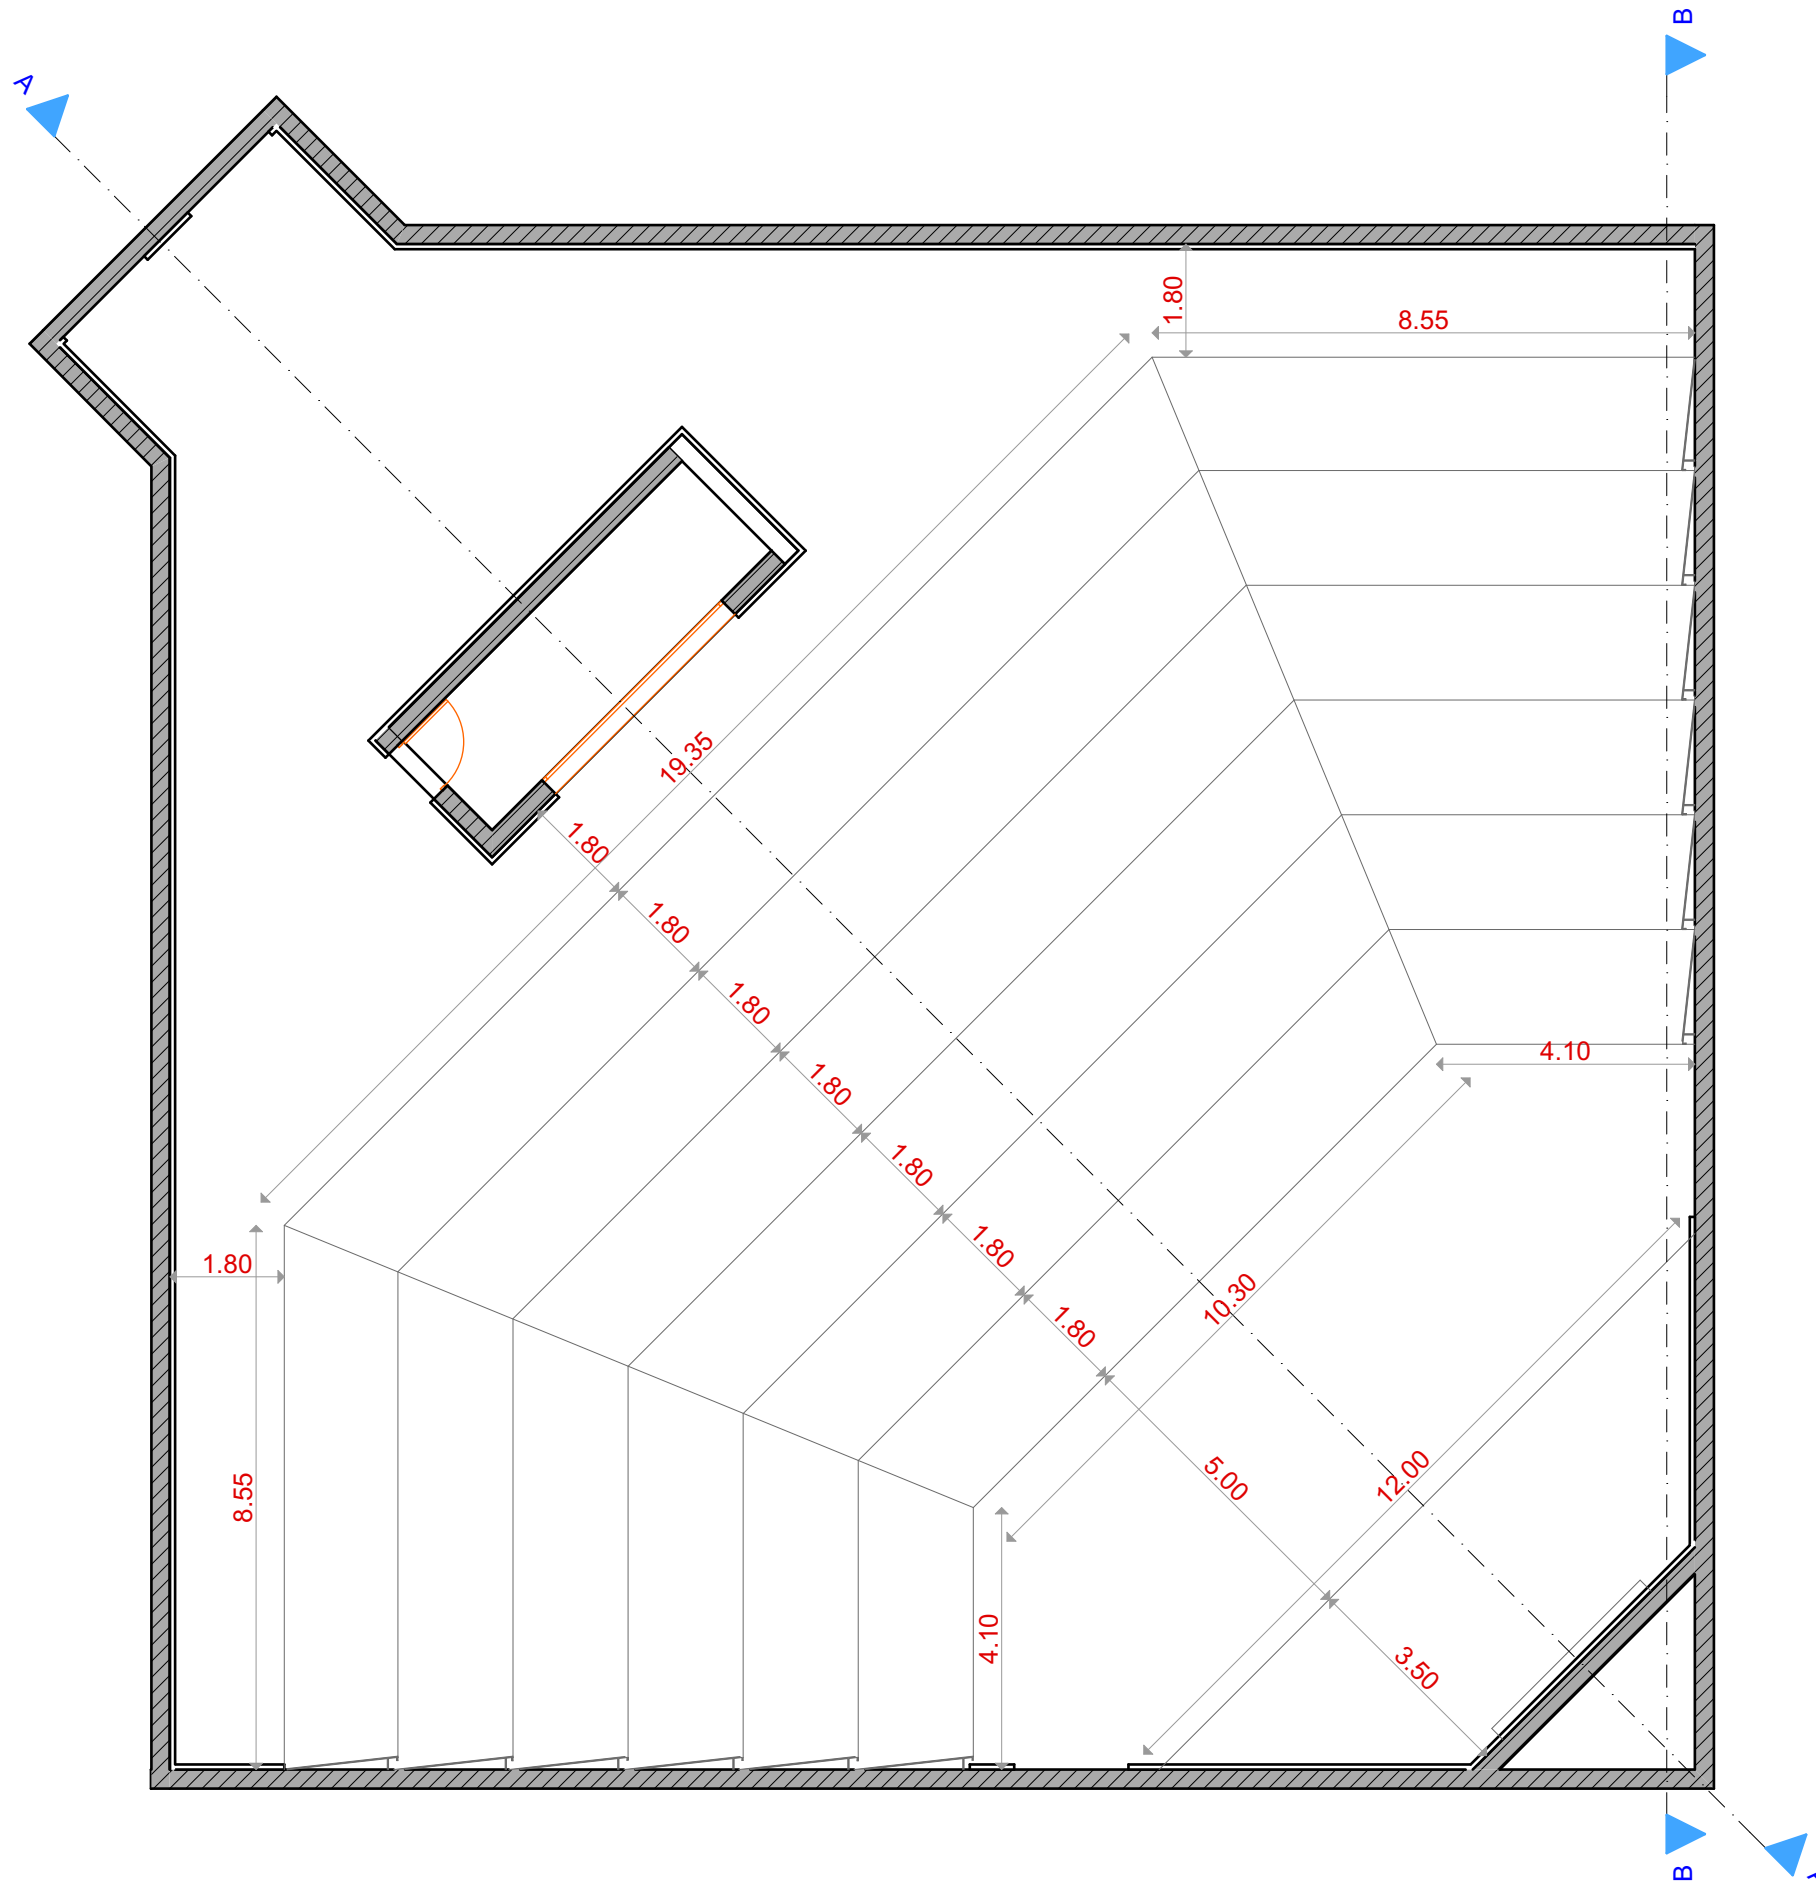

ALL DIMENSIONS ARE IN METER

NO.	REVISION	DATE	APP.

CONTRACTOR

 شركة أبحاث وتصميم عربي

CONSULTANT

 شركة أبحاث وتصميم عربي

CLIENT :
 MINISTRY OF HIGHER EDUCATION & SCIENTIFIC RESEARCH



PROJECT TITLE :
 MINISTRY OF HIGHER EDUCATION CONFERENCE HALL

DRAWING TITLE :
 CEILING DETAILS PLAN

DRAWN BY :
 CHECKED BY :
 APPROVED BY :

FILE NAME :
 DATE :
 MAR / 2014

SHEET NO :

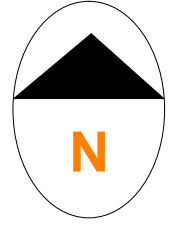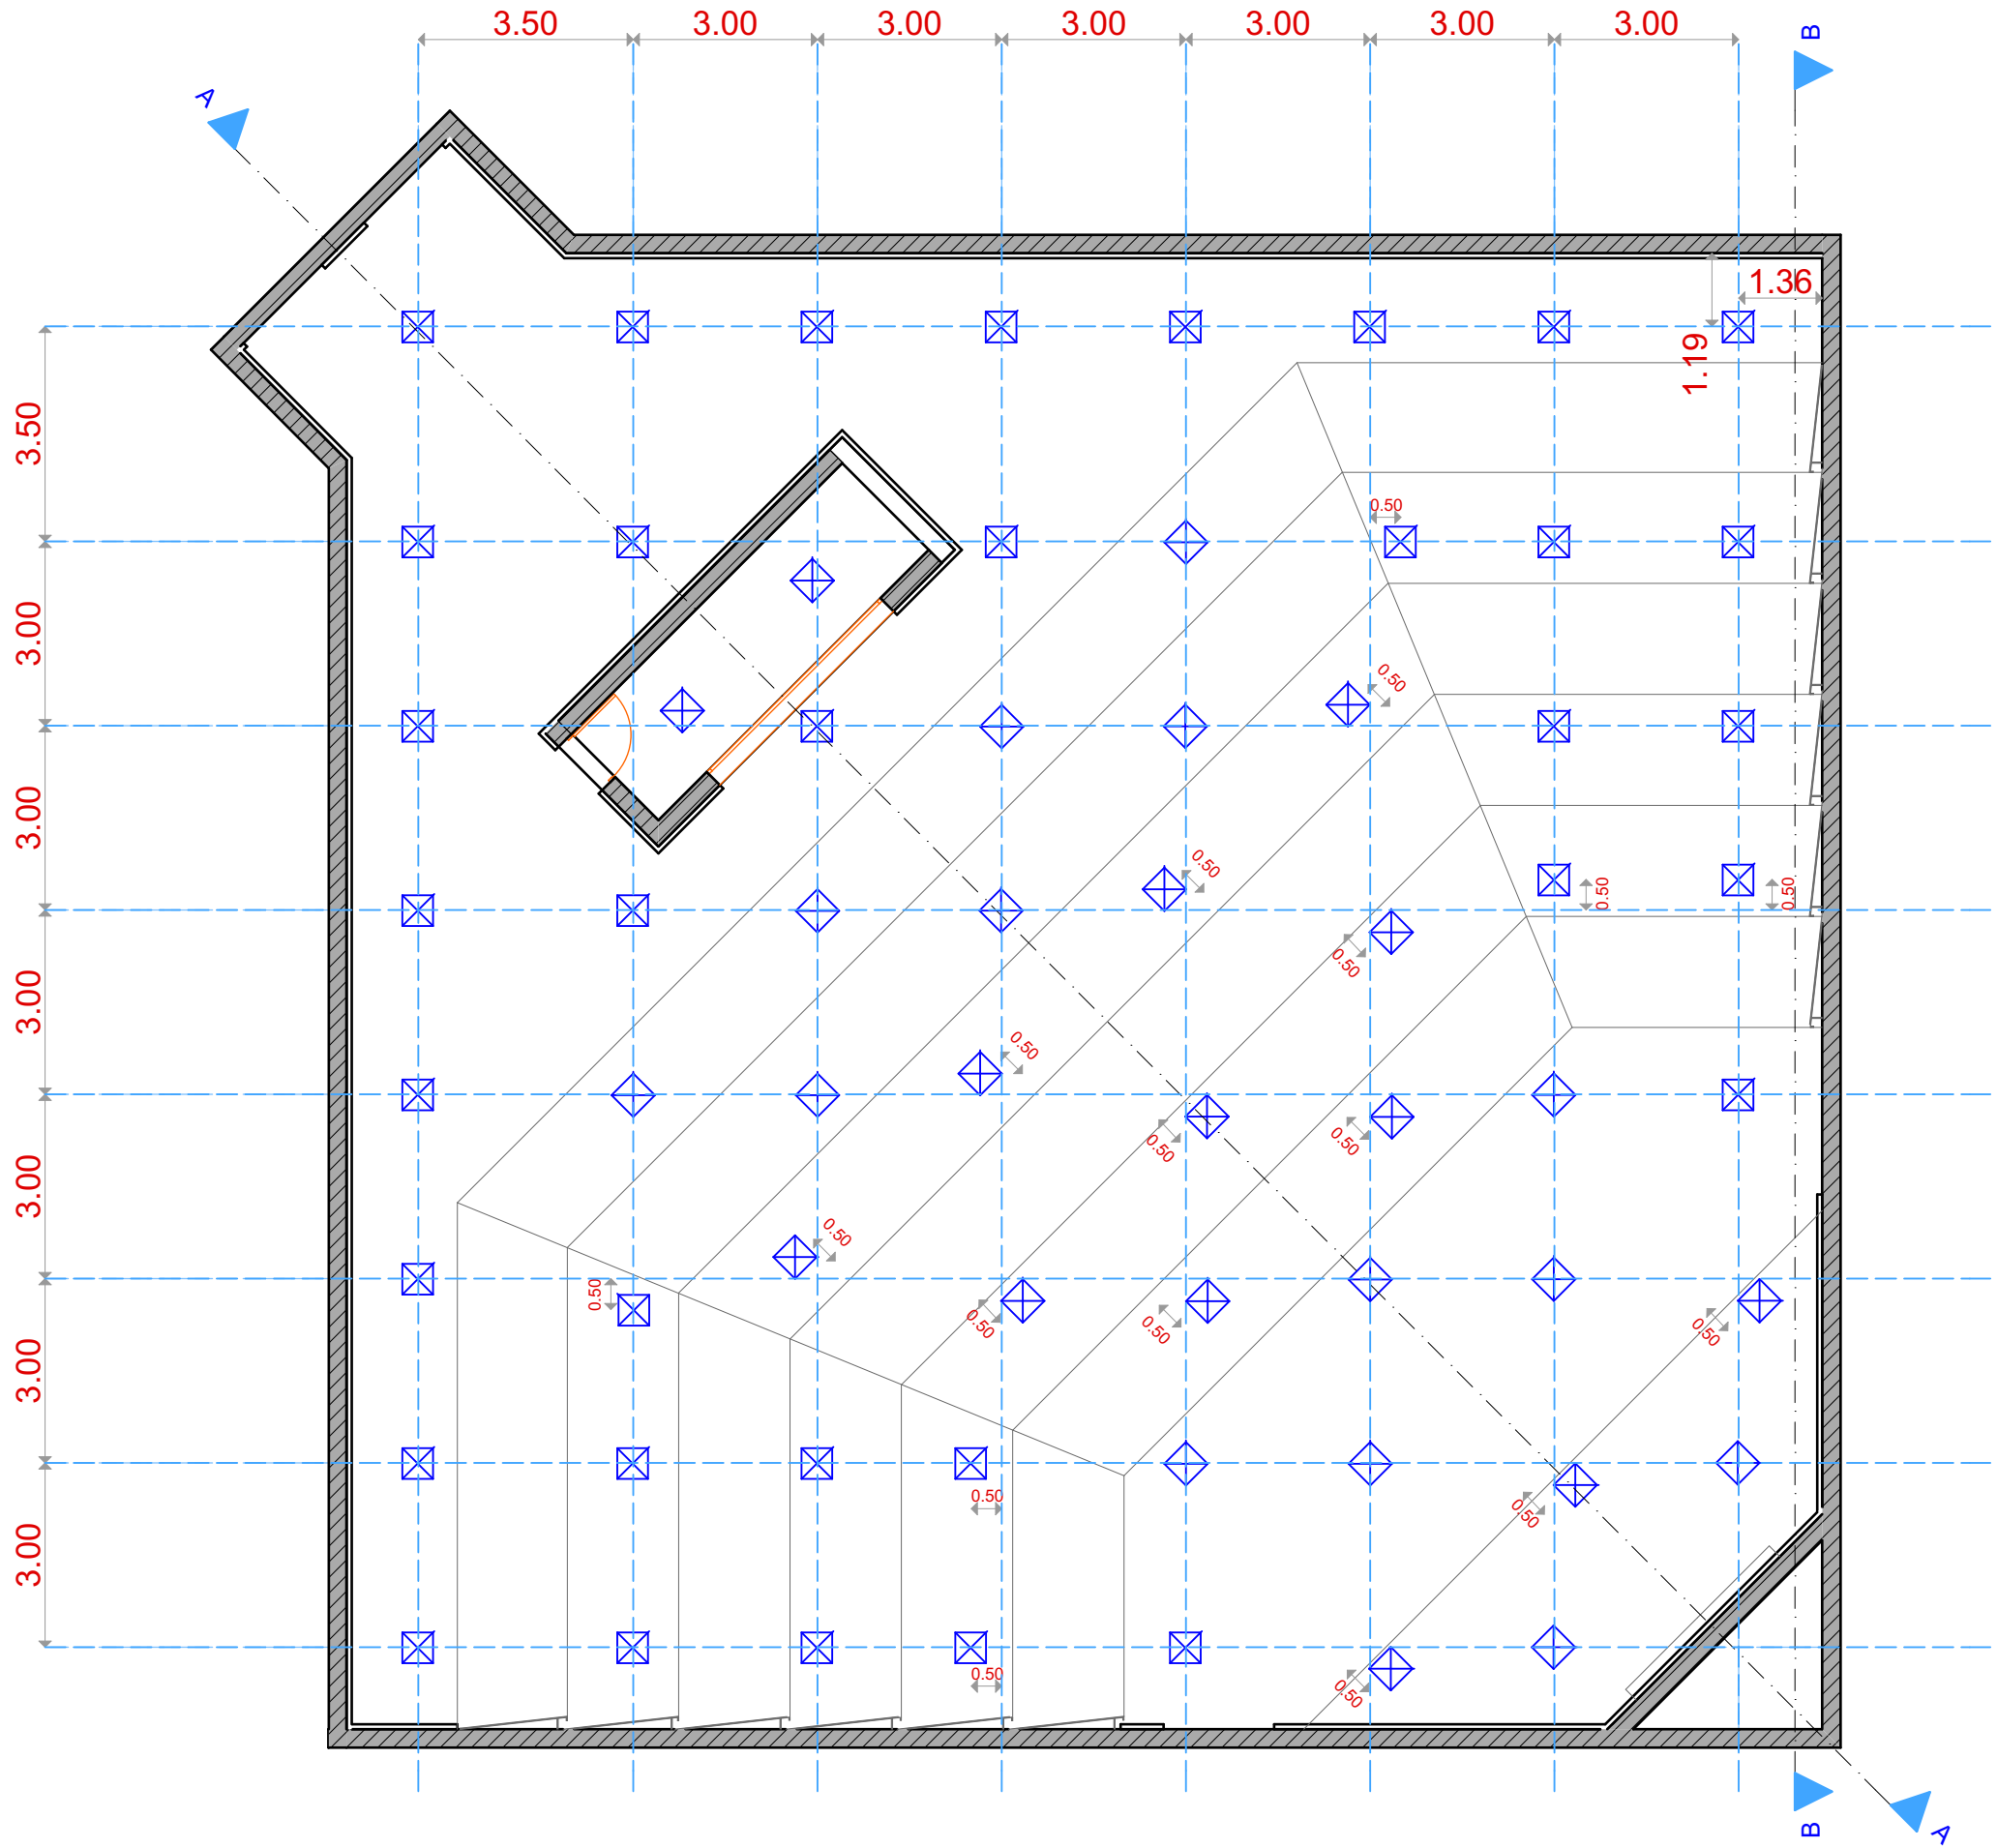

ALL DIMENSIONS ARE IN METER

NO.	REVISION	DATE	APP.

CONTRACTOR

 شركة أبحاث وتصميم

CONSULTANT

 شركة أبحاث وتصميم

CLIENT :
 MINISTRY OF HIGHER EDUCATION & SCIENTIFIC RESEARCH



PROJECT TITLE :
 MINISTRY OF HIGHER EDUCATION CONFERENCE HALL

DRAWING TITLE :
 A/C DIFFUSERS PLAN

DRAWN BY :
 CHECKED BY :
 APPROVED BY :

FILE NAME :
 DATE :
 MAR / 2014

SHEET NO :

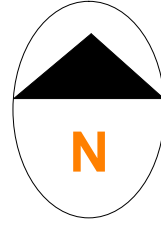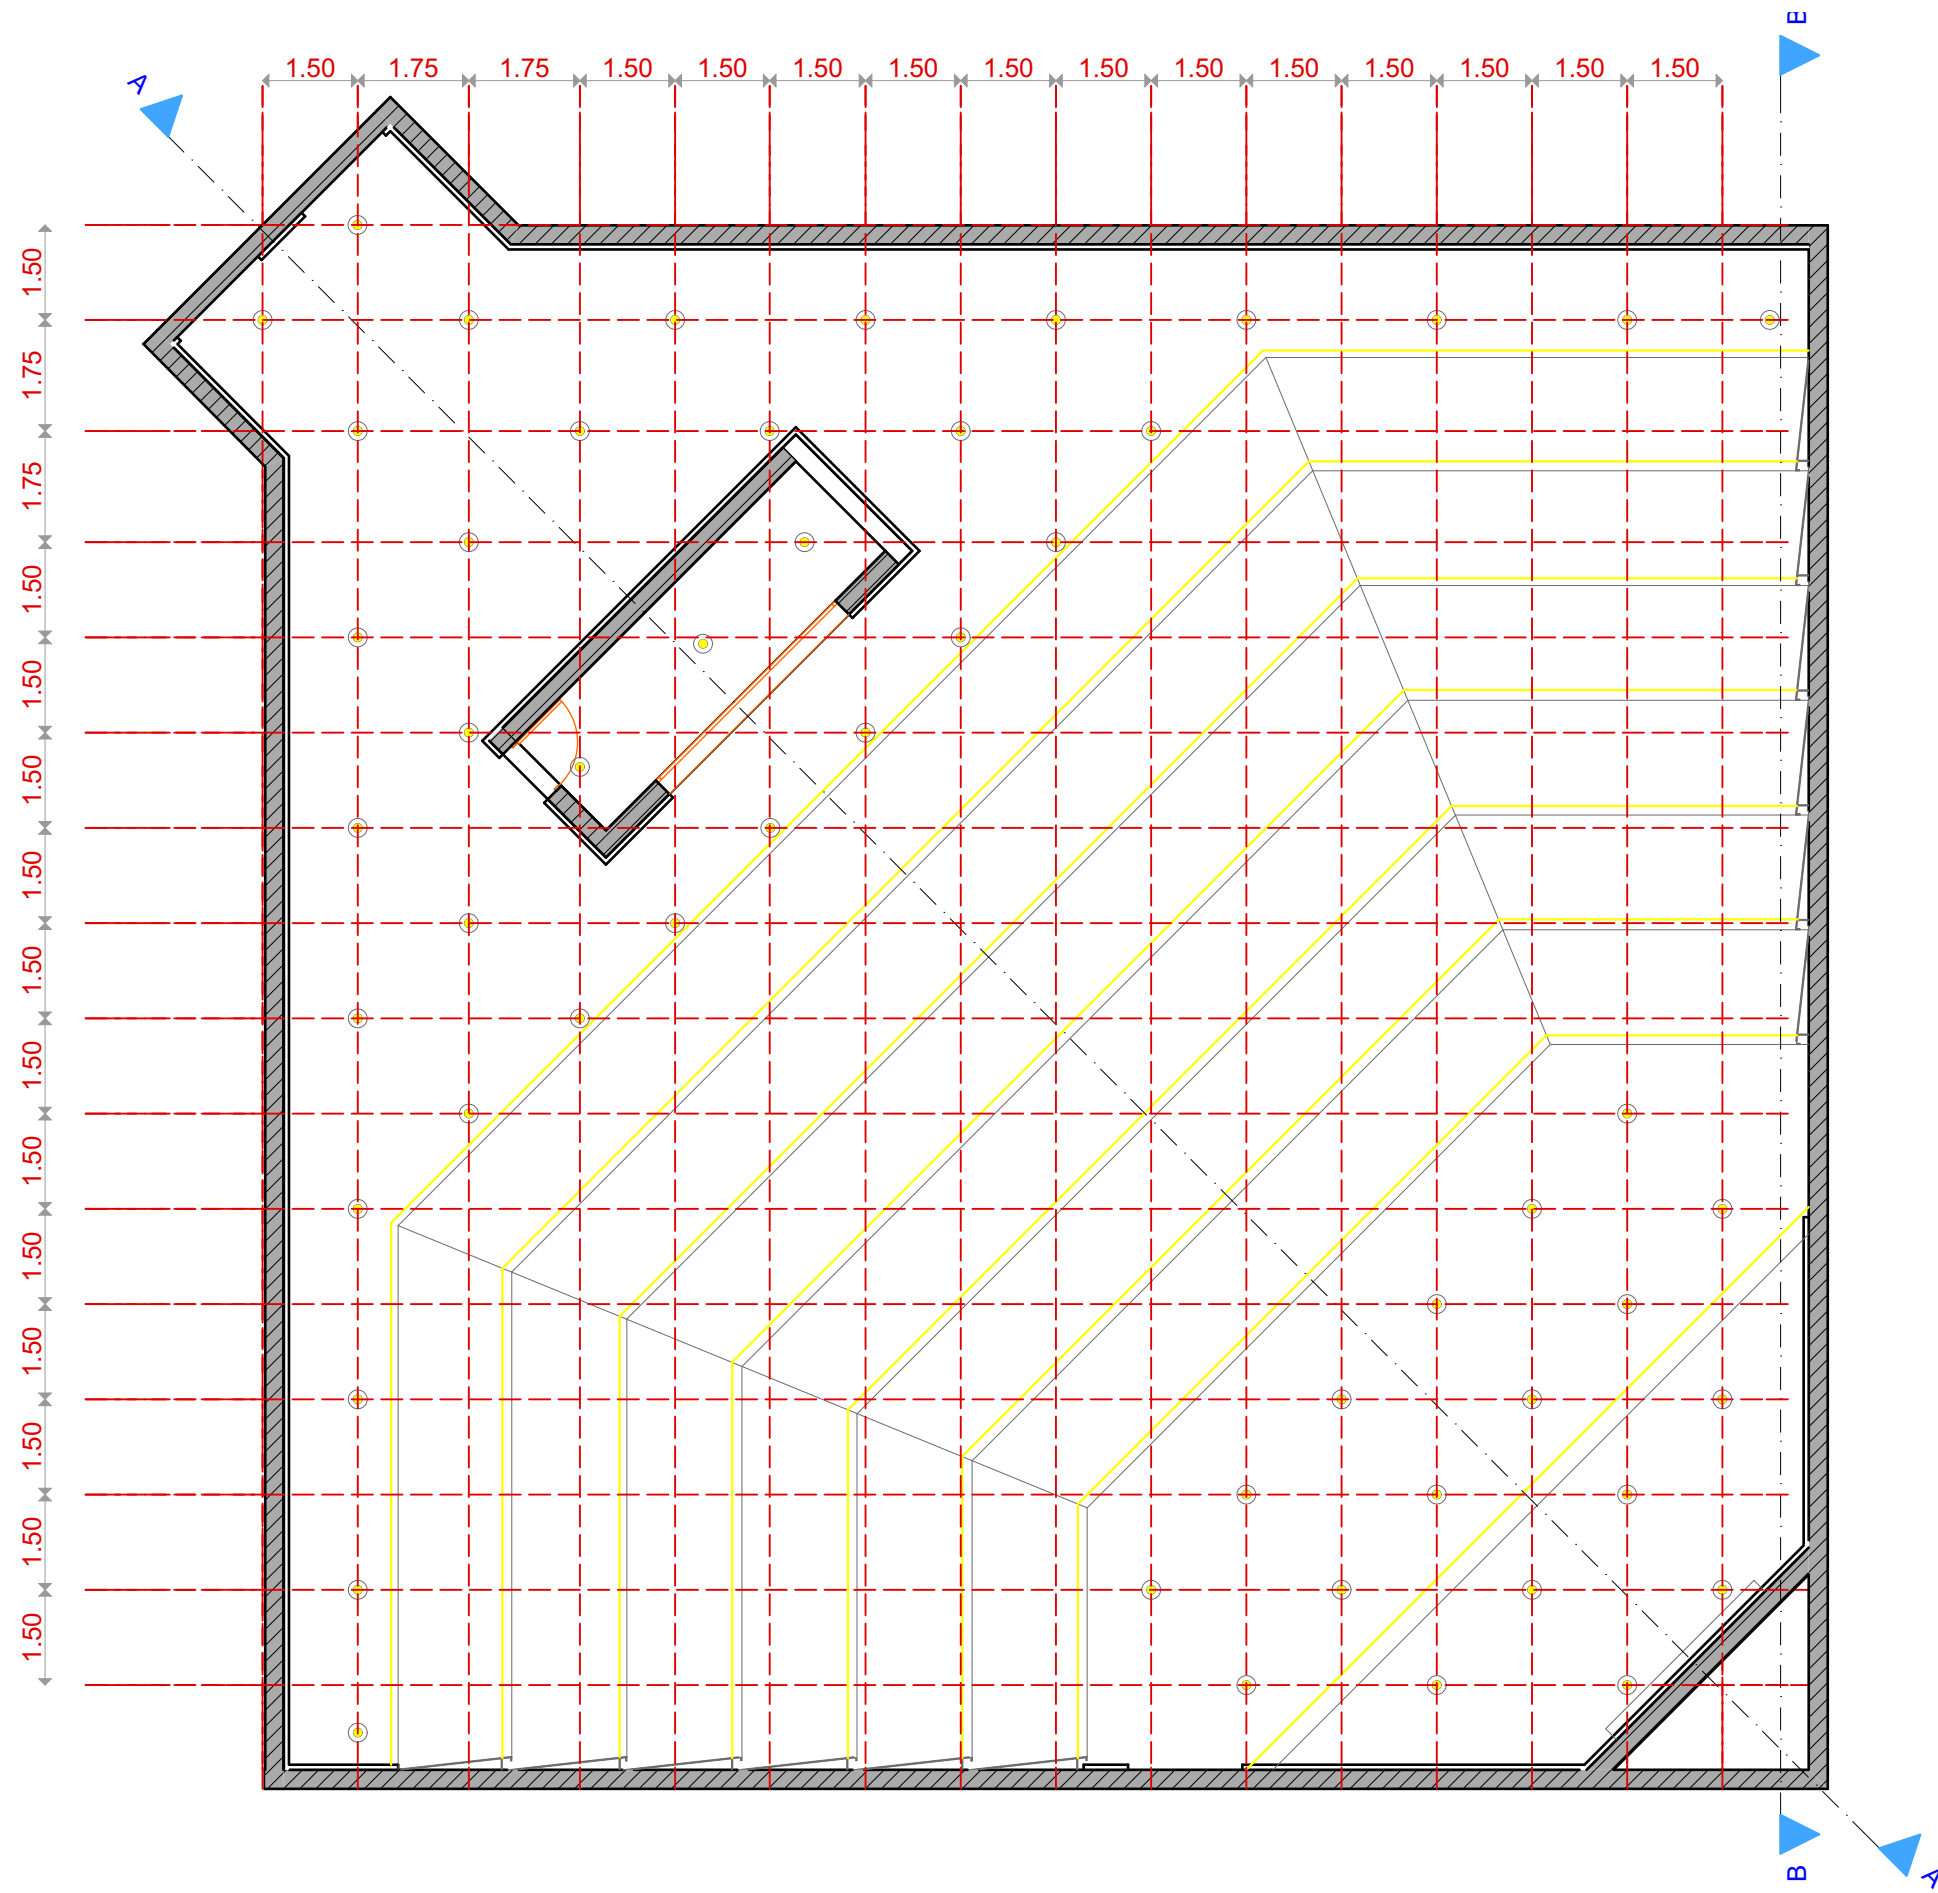

ALL DIMENSIONS ARE IN METER

NO.	REVISION	DATE	APP.

CONTRACTOR
 ARDH شركة ايز للتسويق والاعمال

CONSULTANT
 DAR CONSULT
 شركة دار للتصميم والهندسة المعمارية

CLIENT :
 MINISTRY OF HIGHER EDUCATION & SCIENTIFIC RESEARCH

PROJECT NO :



PROJECT TITLE :
 MINISTRY OF HIGHER EDUCATION CONFERENCE HALL

DRAWING NO :
SCALE :

DRAWING TITLE :
 LIGHTING PLAN

DRAWN BY :
CHECKED BY :
APPROVED BY :

FILE NAME :	DATE : MAR / 2014	SHEET NO :
--------------------	-----------------------------	-------------------

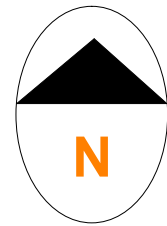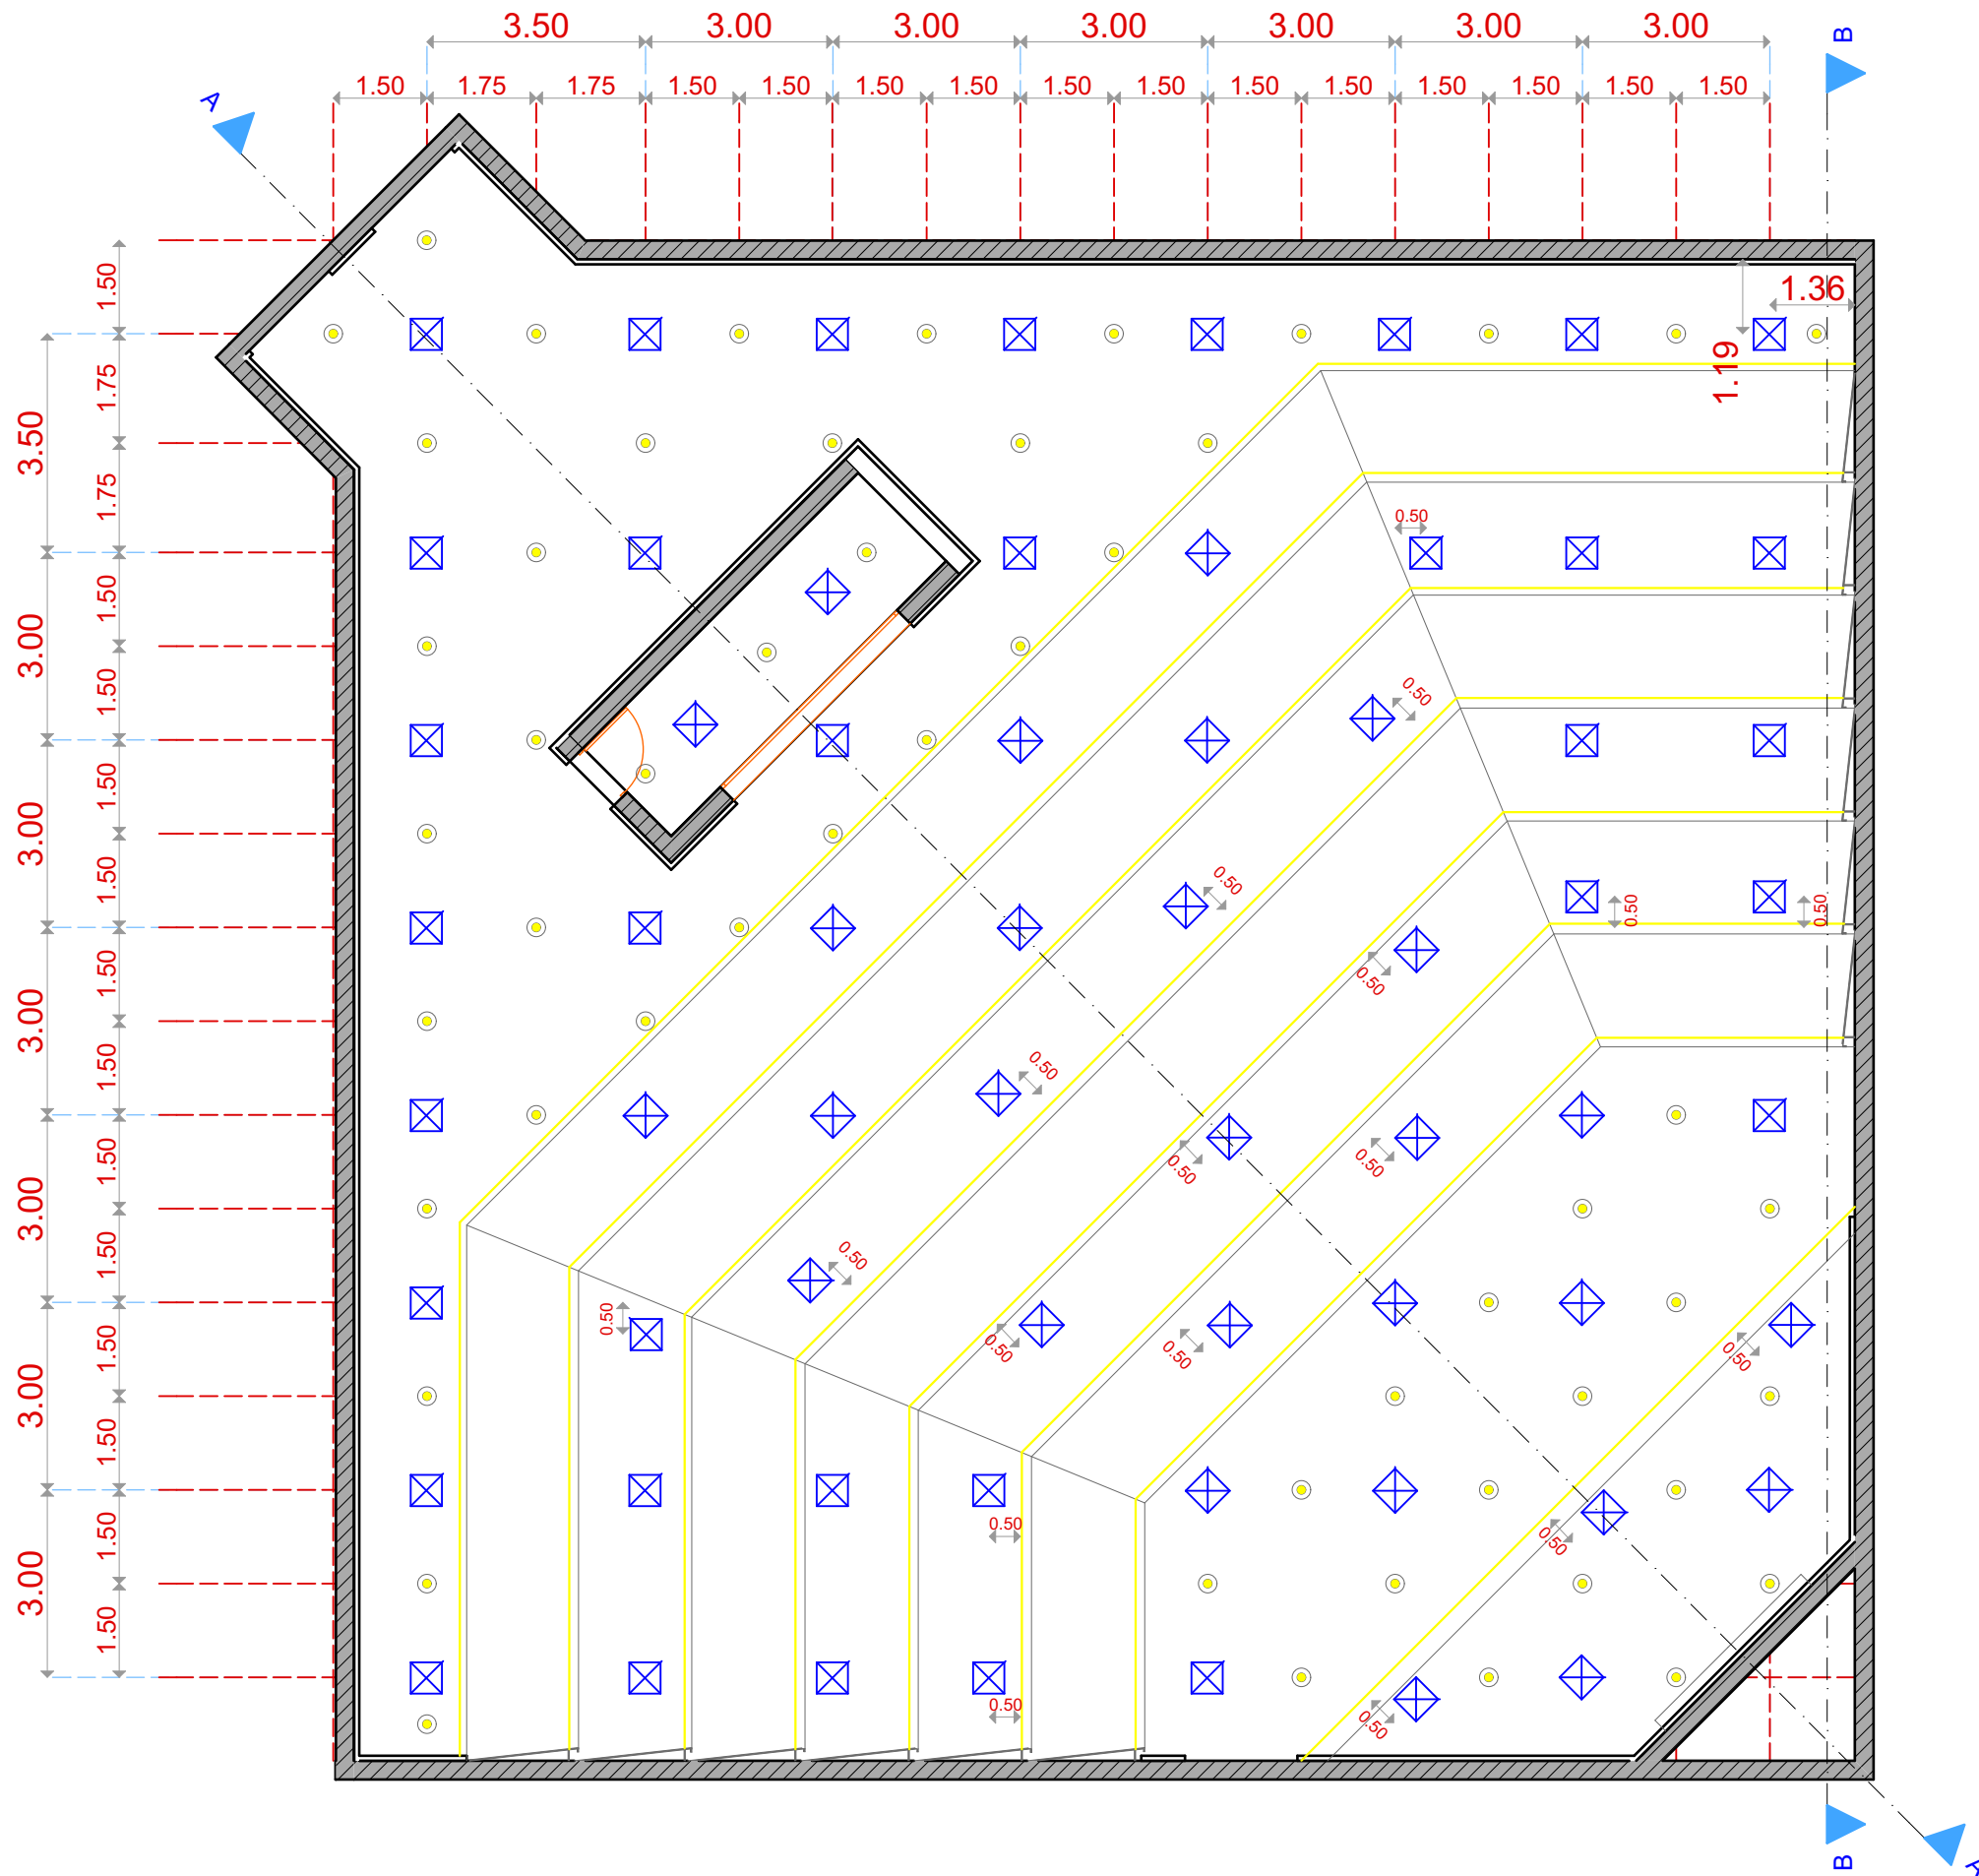

ALL DIMENSIONS ARE IN METER

NO.	REVISION	DATE	APP.

CONTRACTOR

 شركة أبحاث وتصميم الشرق الأوسط

CONSULTANT

 شركة أبحاث وتصميم الشرق الأوسط

CLIENT :
 MINISTRY OF HIGHER EDUCATION & SCIENTIFIC RESEARCH

PROJECT NO :

PROJECT TITLE :
 MINISTRY OF HIGHER EDUCATION CONFERENCE HALL



DRAWING NO :
 SCALE :

DRAWING TITLE :
GENERAL CEILING PLAN

DRAWN BY :
 CHECKED BY :
 APPROVED BY :

FILE NAME :
 DATE :
 MAR / 2014

SHEET NO :

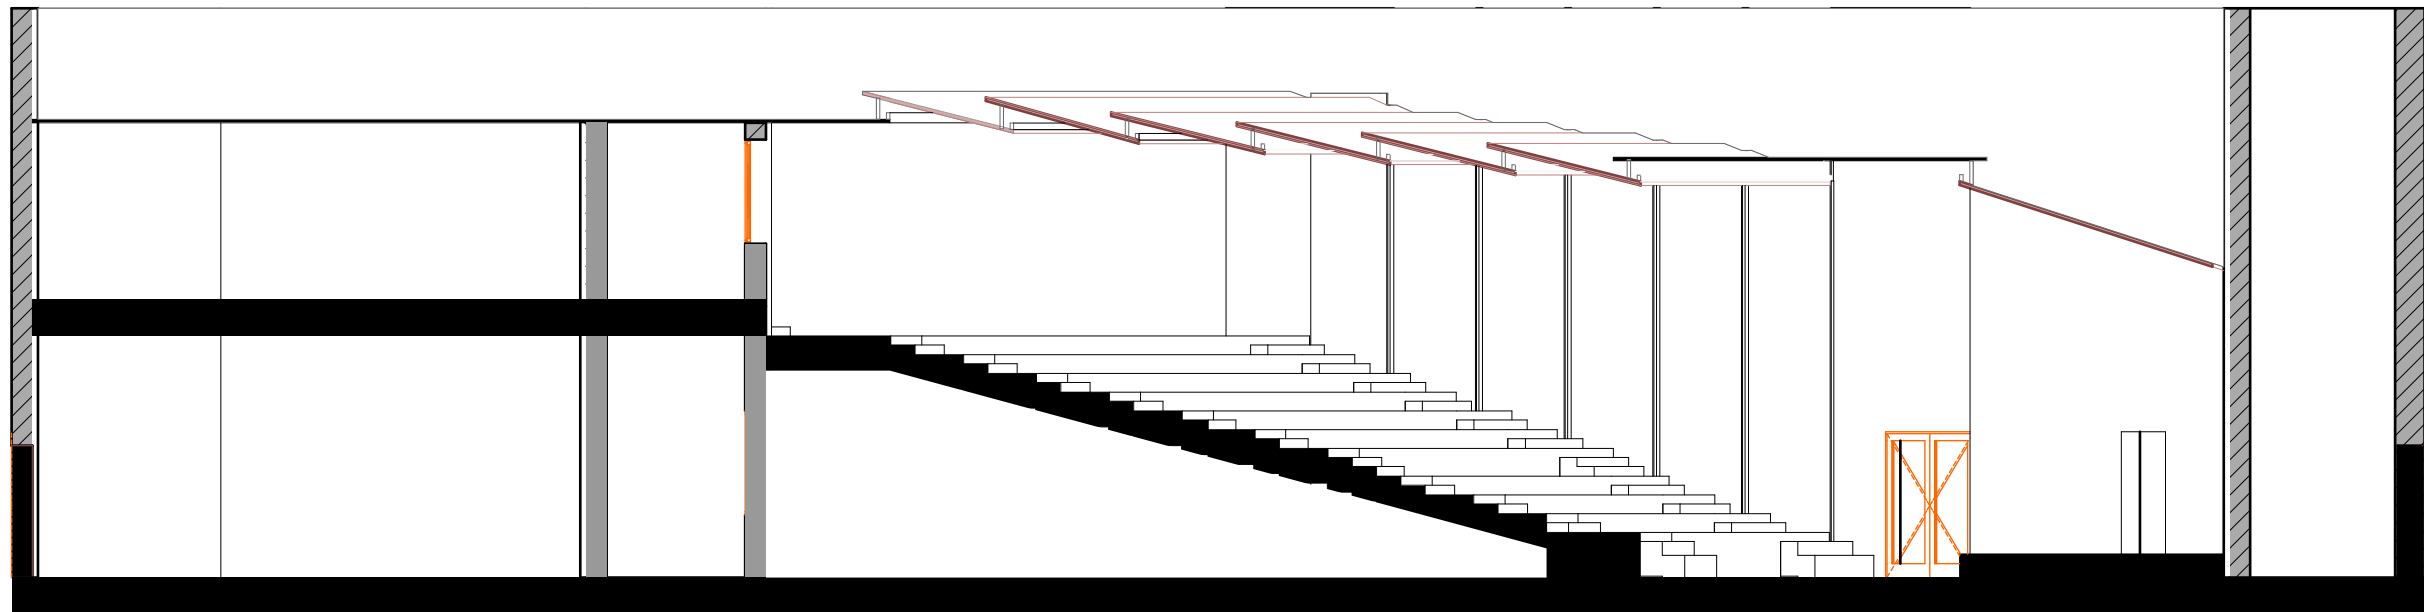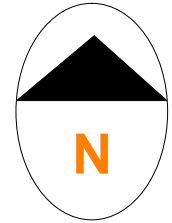

ALL DIMENSIONS ARE IN METER

NO.	REVISION	DATE	APP.

CONTRACTOR

 شركة أبحاث وتصميم

CONSULTANT
DAR CONSULT
 شركة أبحاث وتصميم

CLIENT :
 MINISTRY OF HIGHER EDUCATION
 & SCIENTIFIC RESEARCH

PROJECT NO :


PROJECT TITLE :
 MINISTRY OF HIGHER EDUCATION
 CONFERENCE HALL

DRAWING NO :
SCALE :



DRAWING TITLE :
SECTION A-A

DRAWN BY :
CHECKED BY :
APPROVED BY :

FILE NAME :	DATE : MAR / 2014	SHEET NO :
--------------------	-----------------------------	-------------------

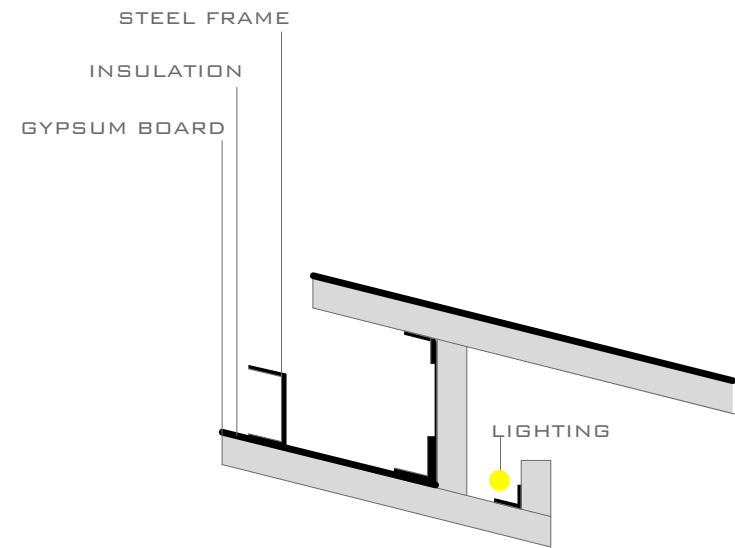

D3

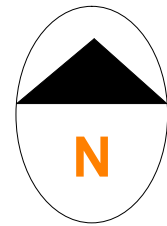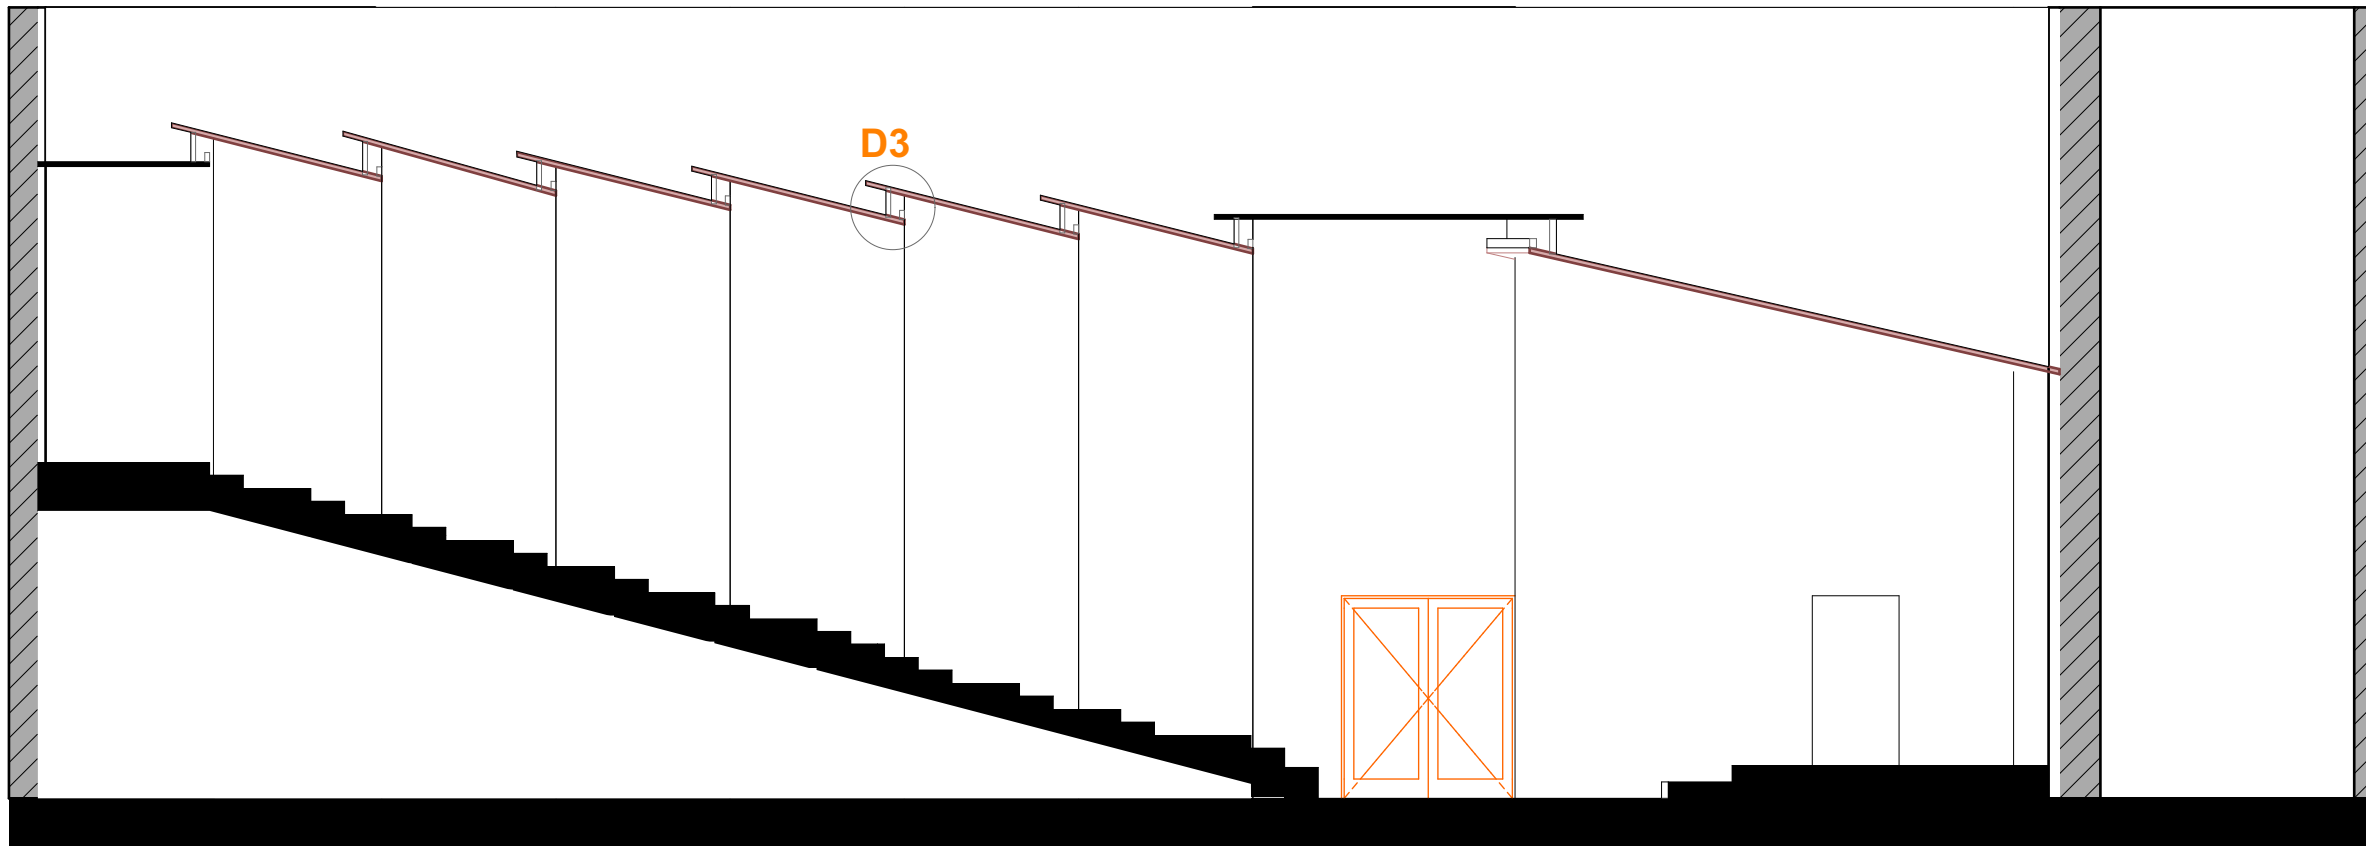

ALL DIMENSIONS ARE IN METER

NO.	REVISION	DATE	APP.

CONTRACTOR
 شركة أبحاث واستشارات

CONSULTANT
 **DAR CONSULT**
 شركة أبحاث واستشارات



CLIENT : MINISTRY OF HIGHER EDUCATION & SCIENTIFIC RESEARCH
PROJECT NO :

PROJECT TITLE : MINISTRY OF HIGHER EDUCATION CONFERENCE HALL
DRAWING NO :
SCALE :

DRAWING TITLE : SECTION B-B

DRAWN BY :
CHECKED BY :
APPROVED BY :

FILE NAME :	DATE : MAR / 2014	SHEET NO :
--------------------	--------------------------	-------------------

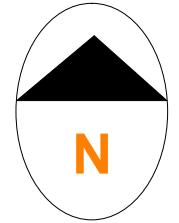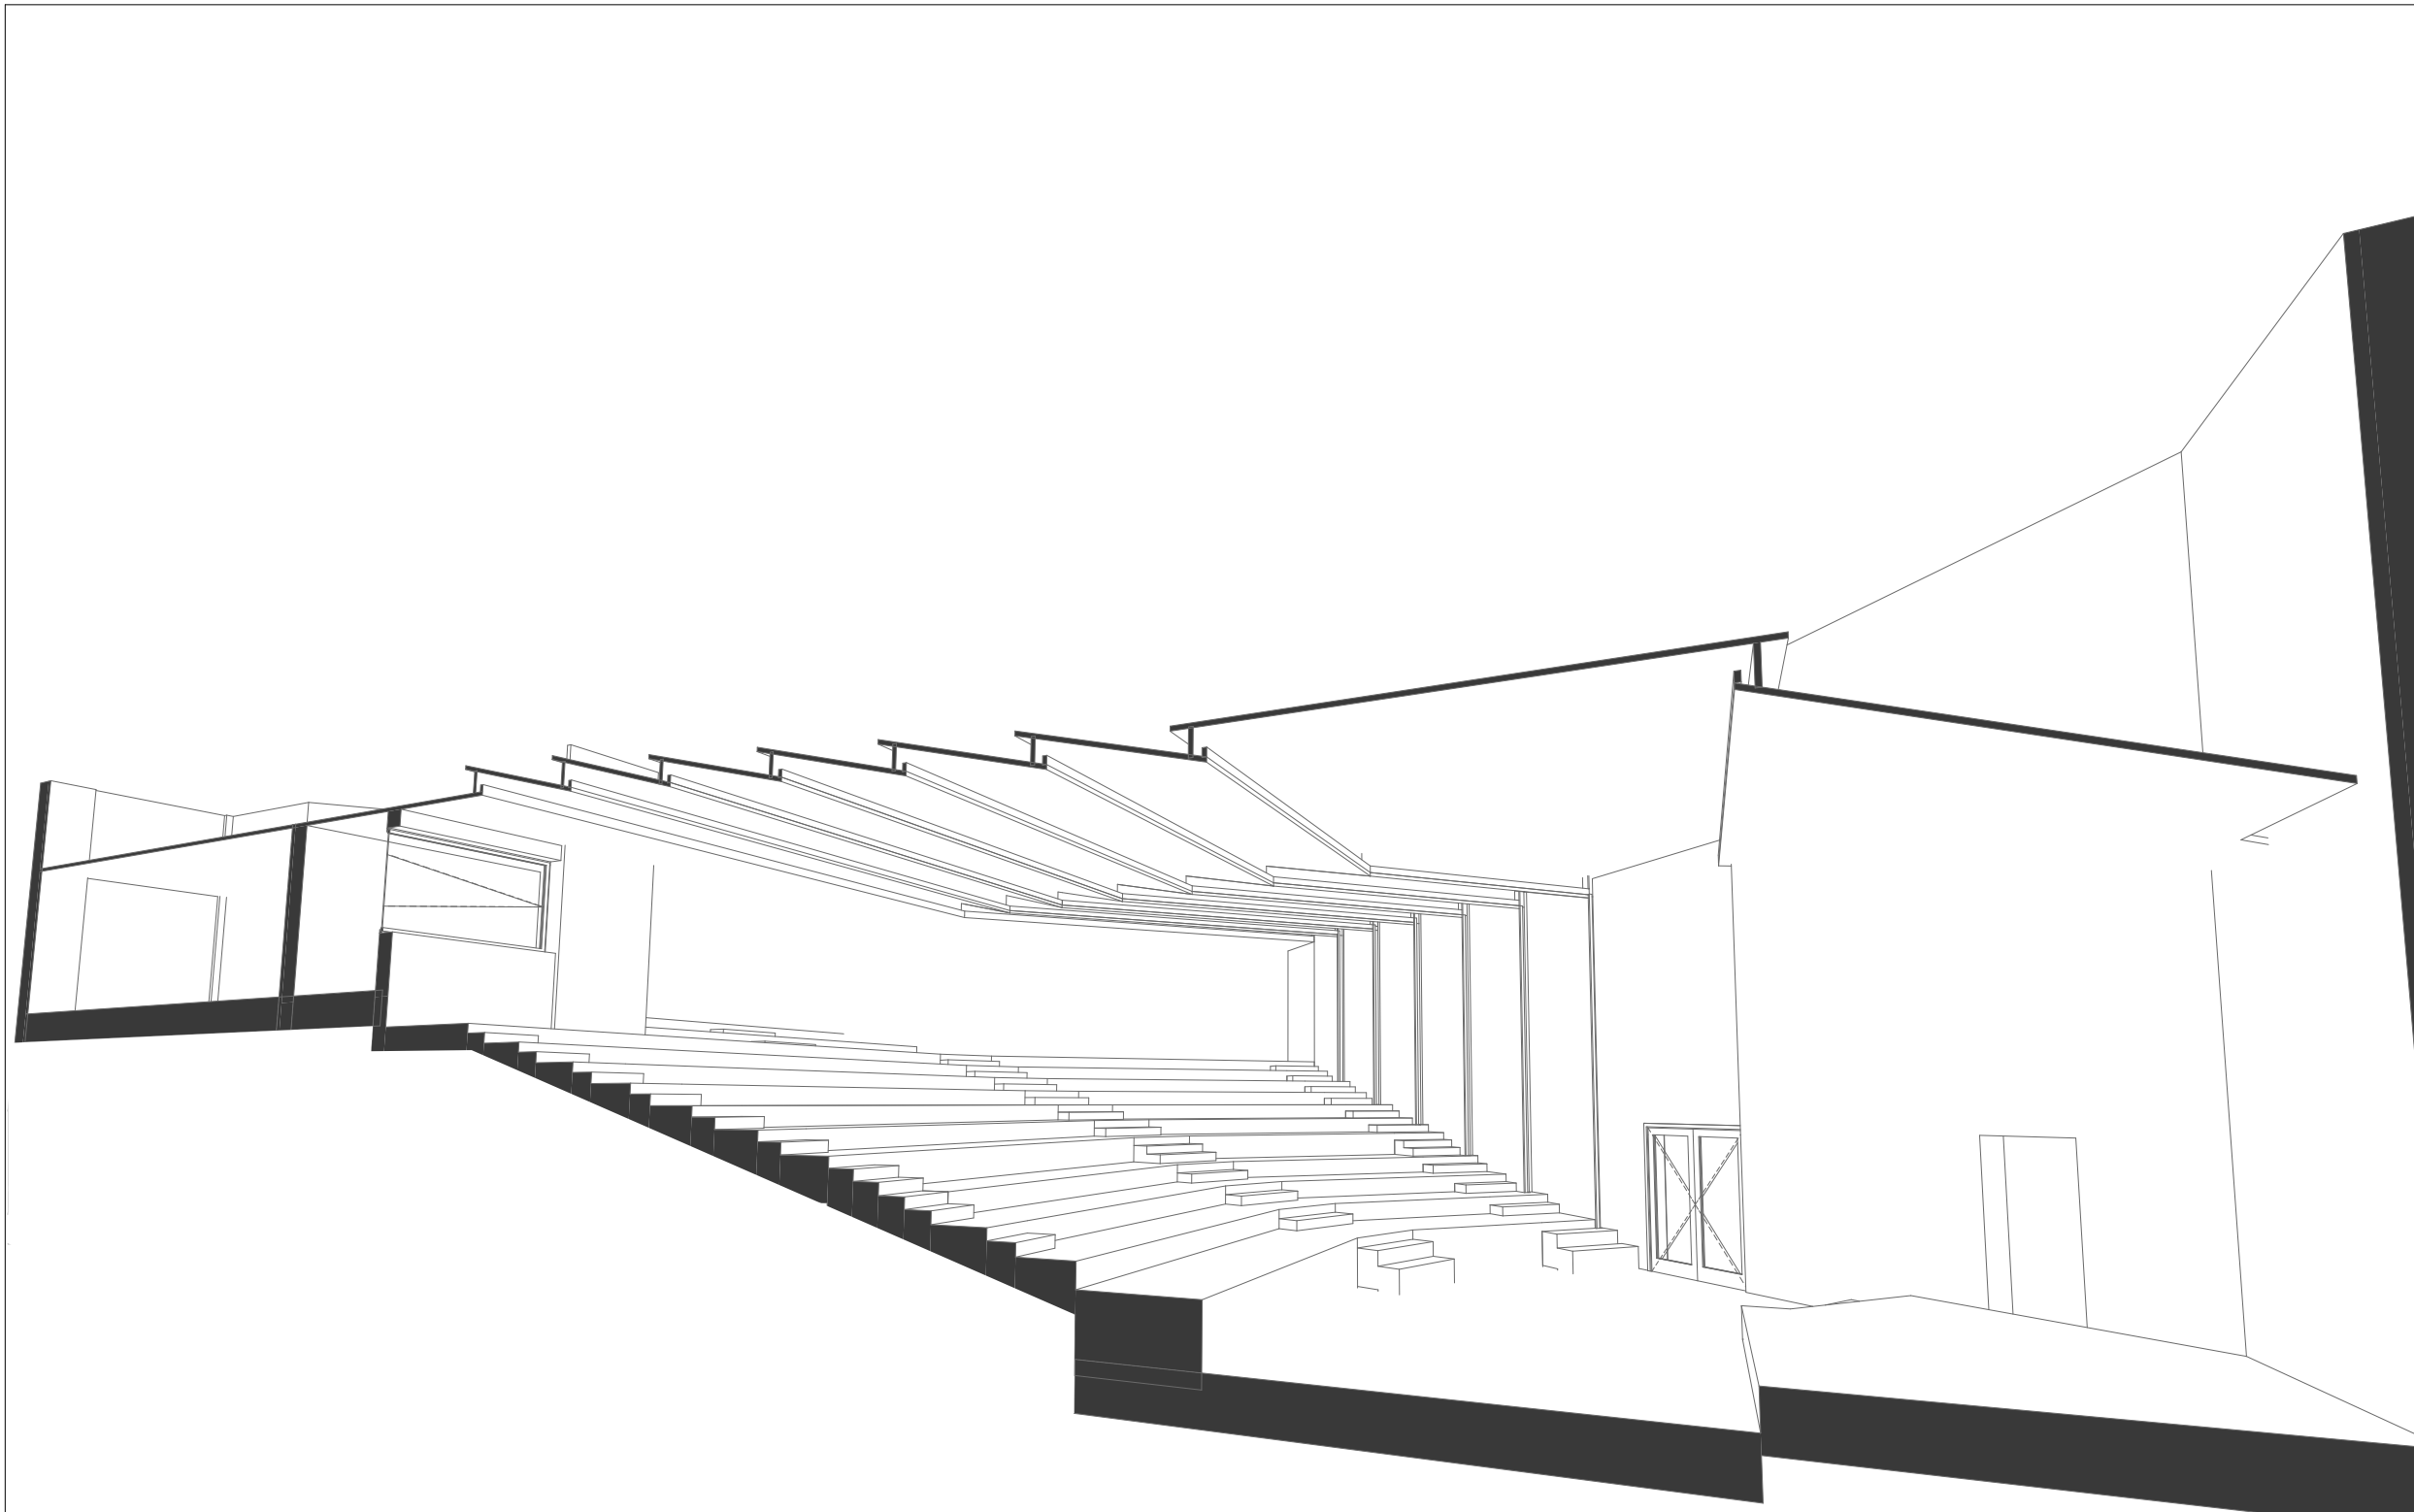

ALL DIMENSIONS ARE IN METER

NO.	REVISION	DATE	APP.

CONTRACTOR

CONSULTANT

CLIENT :
 MINISTRY OF HIGHER EDUCATION
 & SCIENTIFIC RESEARCH

PROJECT NO :

PROJECT TITLE :
 MINISTRY OF HIGHER EDUCATION
 CONFERENCE HALL

DRAWING NO :

SCALE :

DRAWING TITLE :
 3D SECTION

DRAWN BY :

CHECKED BY :

APPROVED BY :

FILE NAME :	DATE : MAR / 2014	SHEET NO :
--------------------	-----------------------------	-------------------