


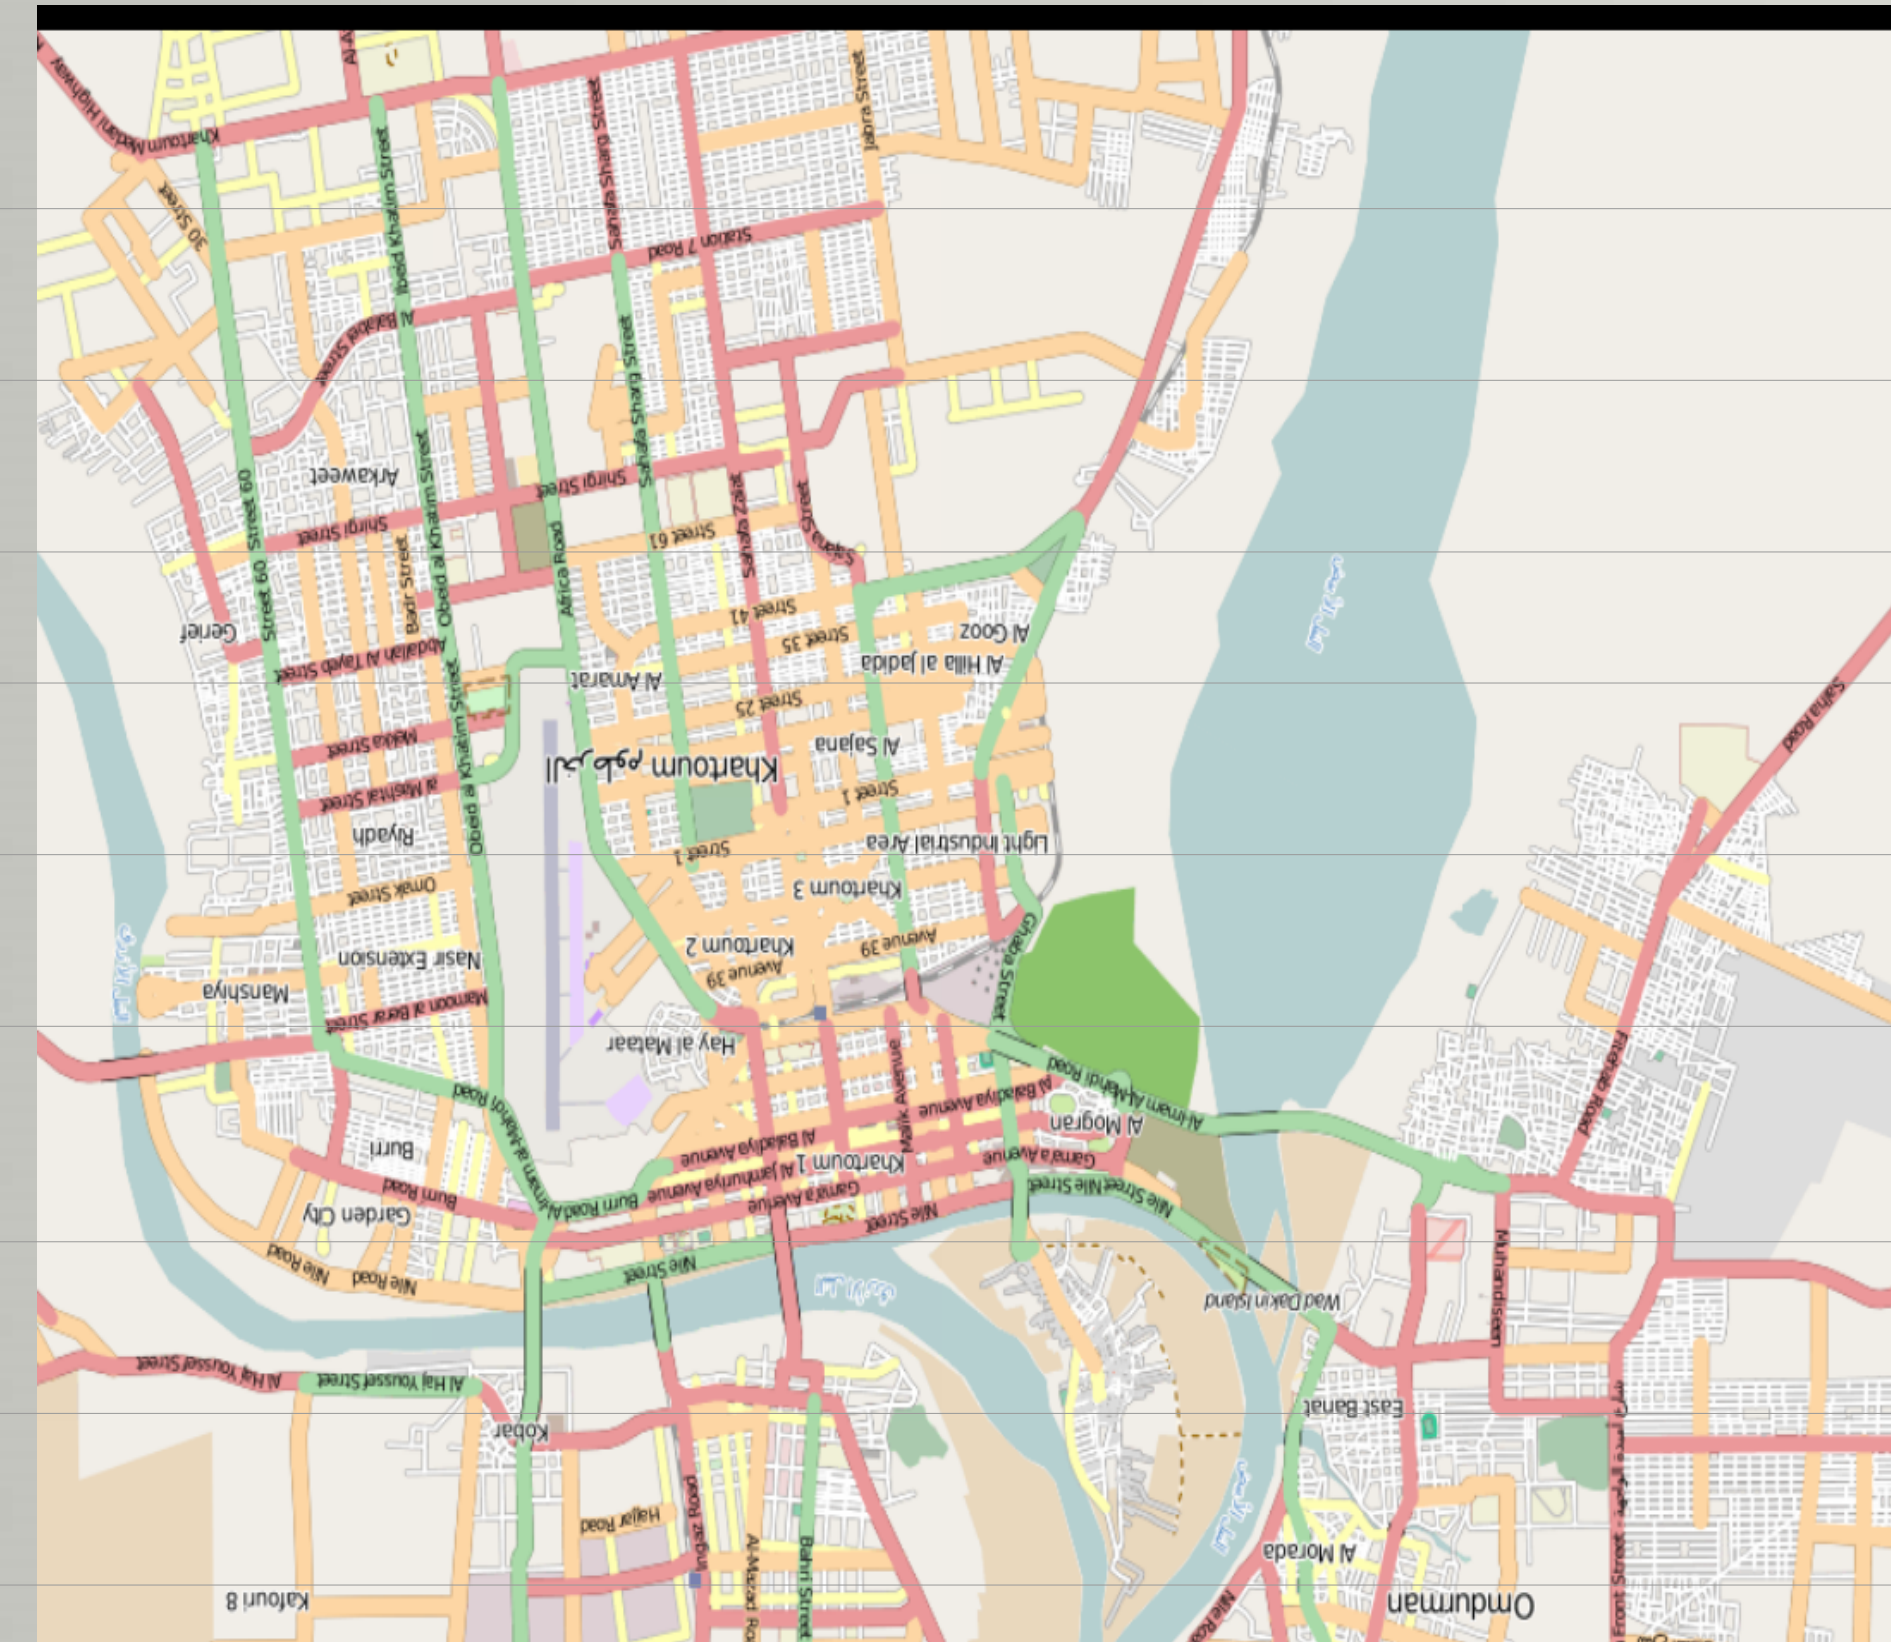




Ruaa Abbas Gareeb Allah

OF
MEDICAL
SCIENCES

FUTURE
EXPANSION

WATER
PLANT

COMPLEX
CHURCHES

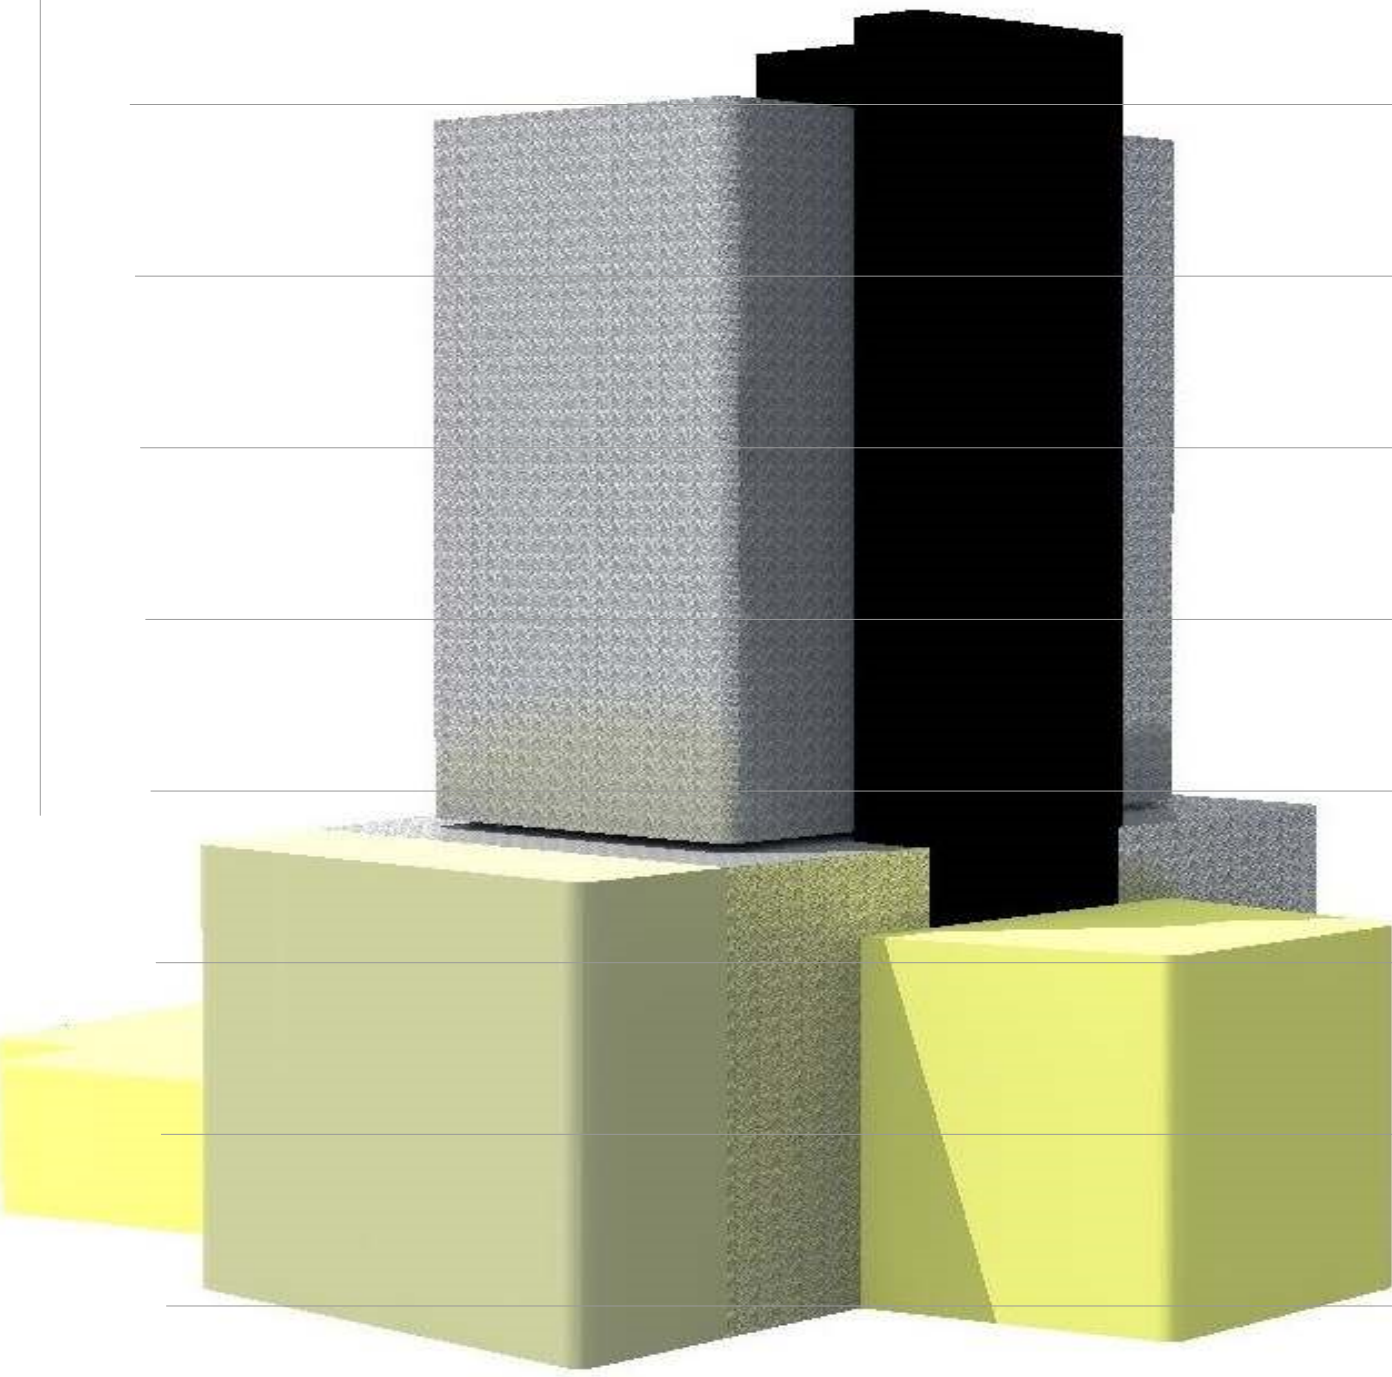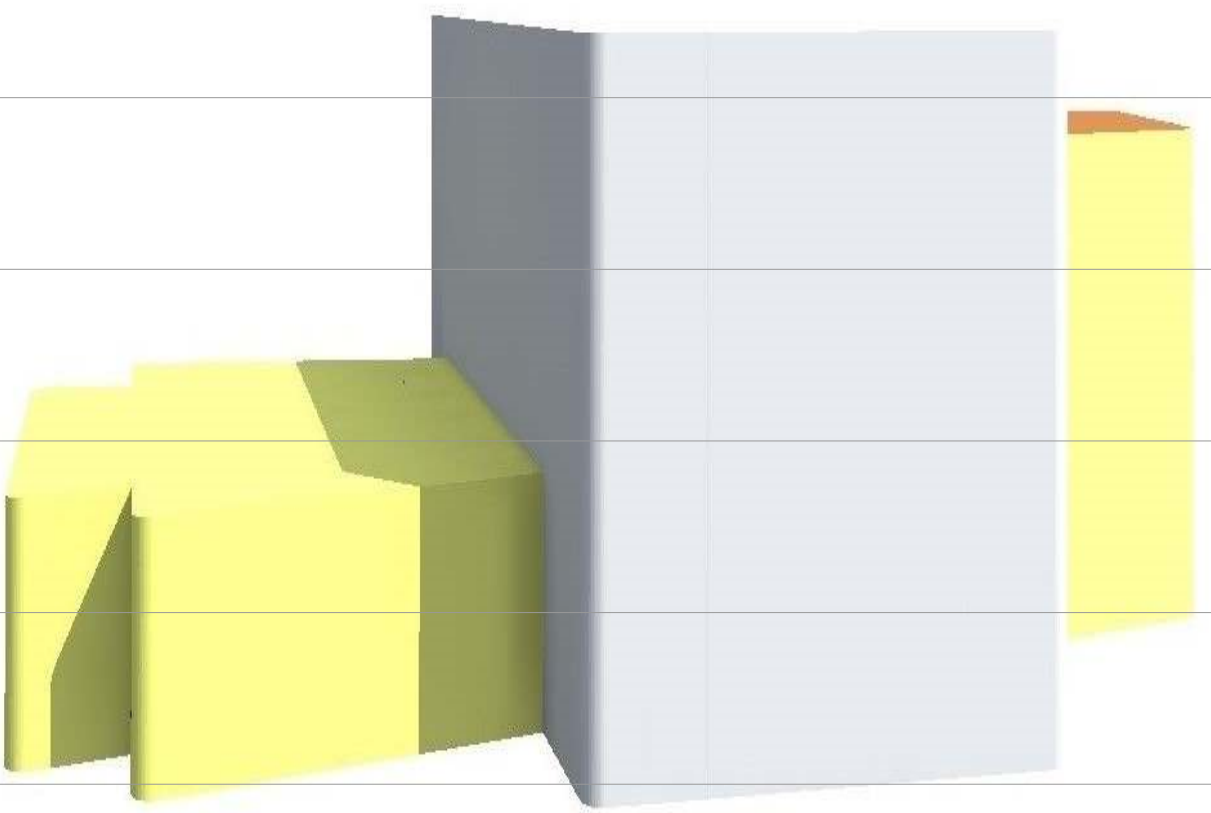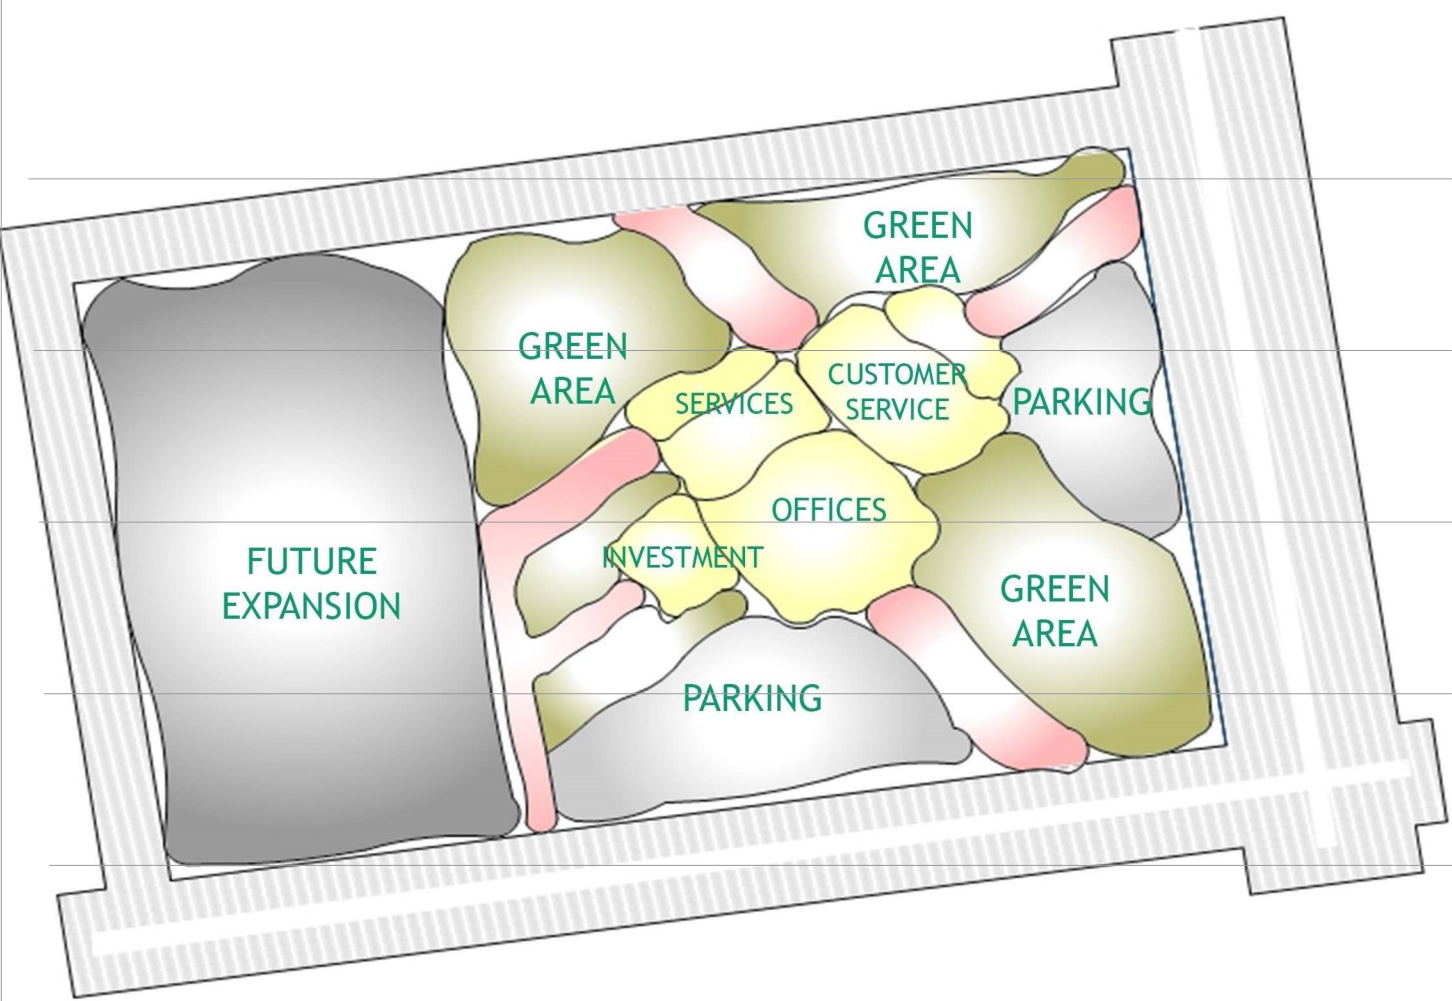

SITE PLAN scale 1:500

Sudan University Of Science And Technology

5 year